
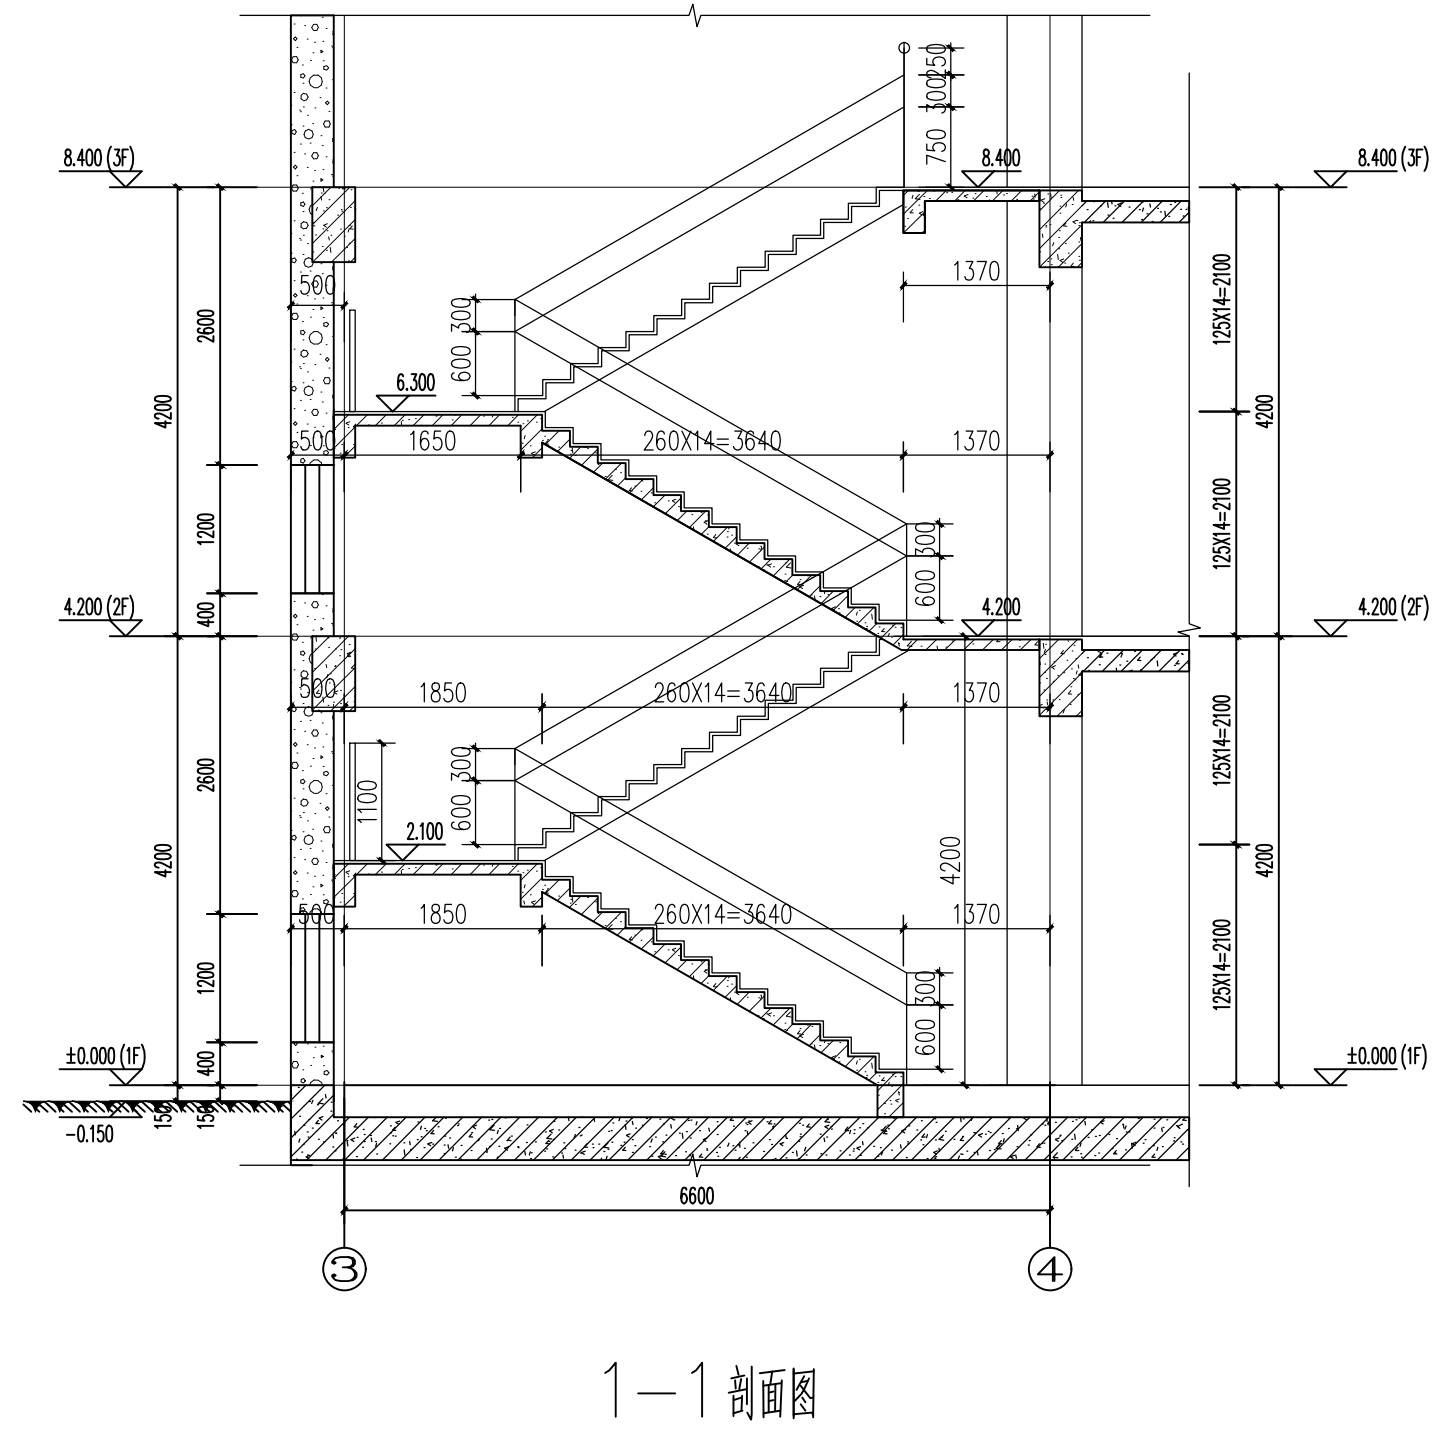
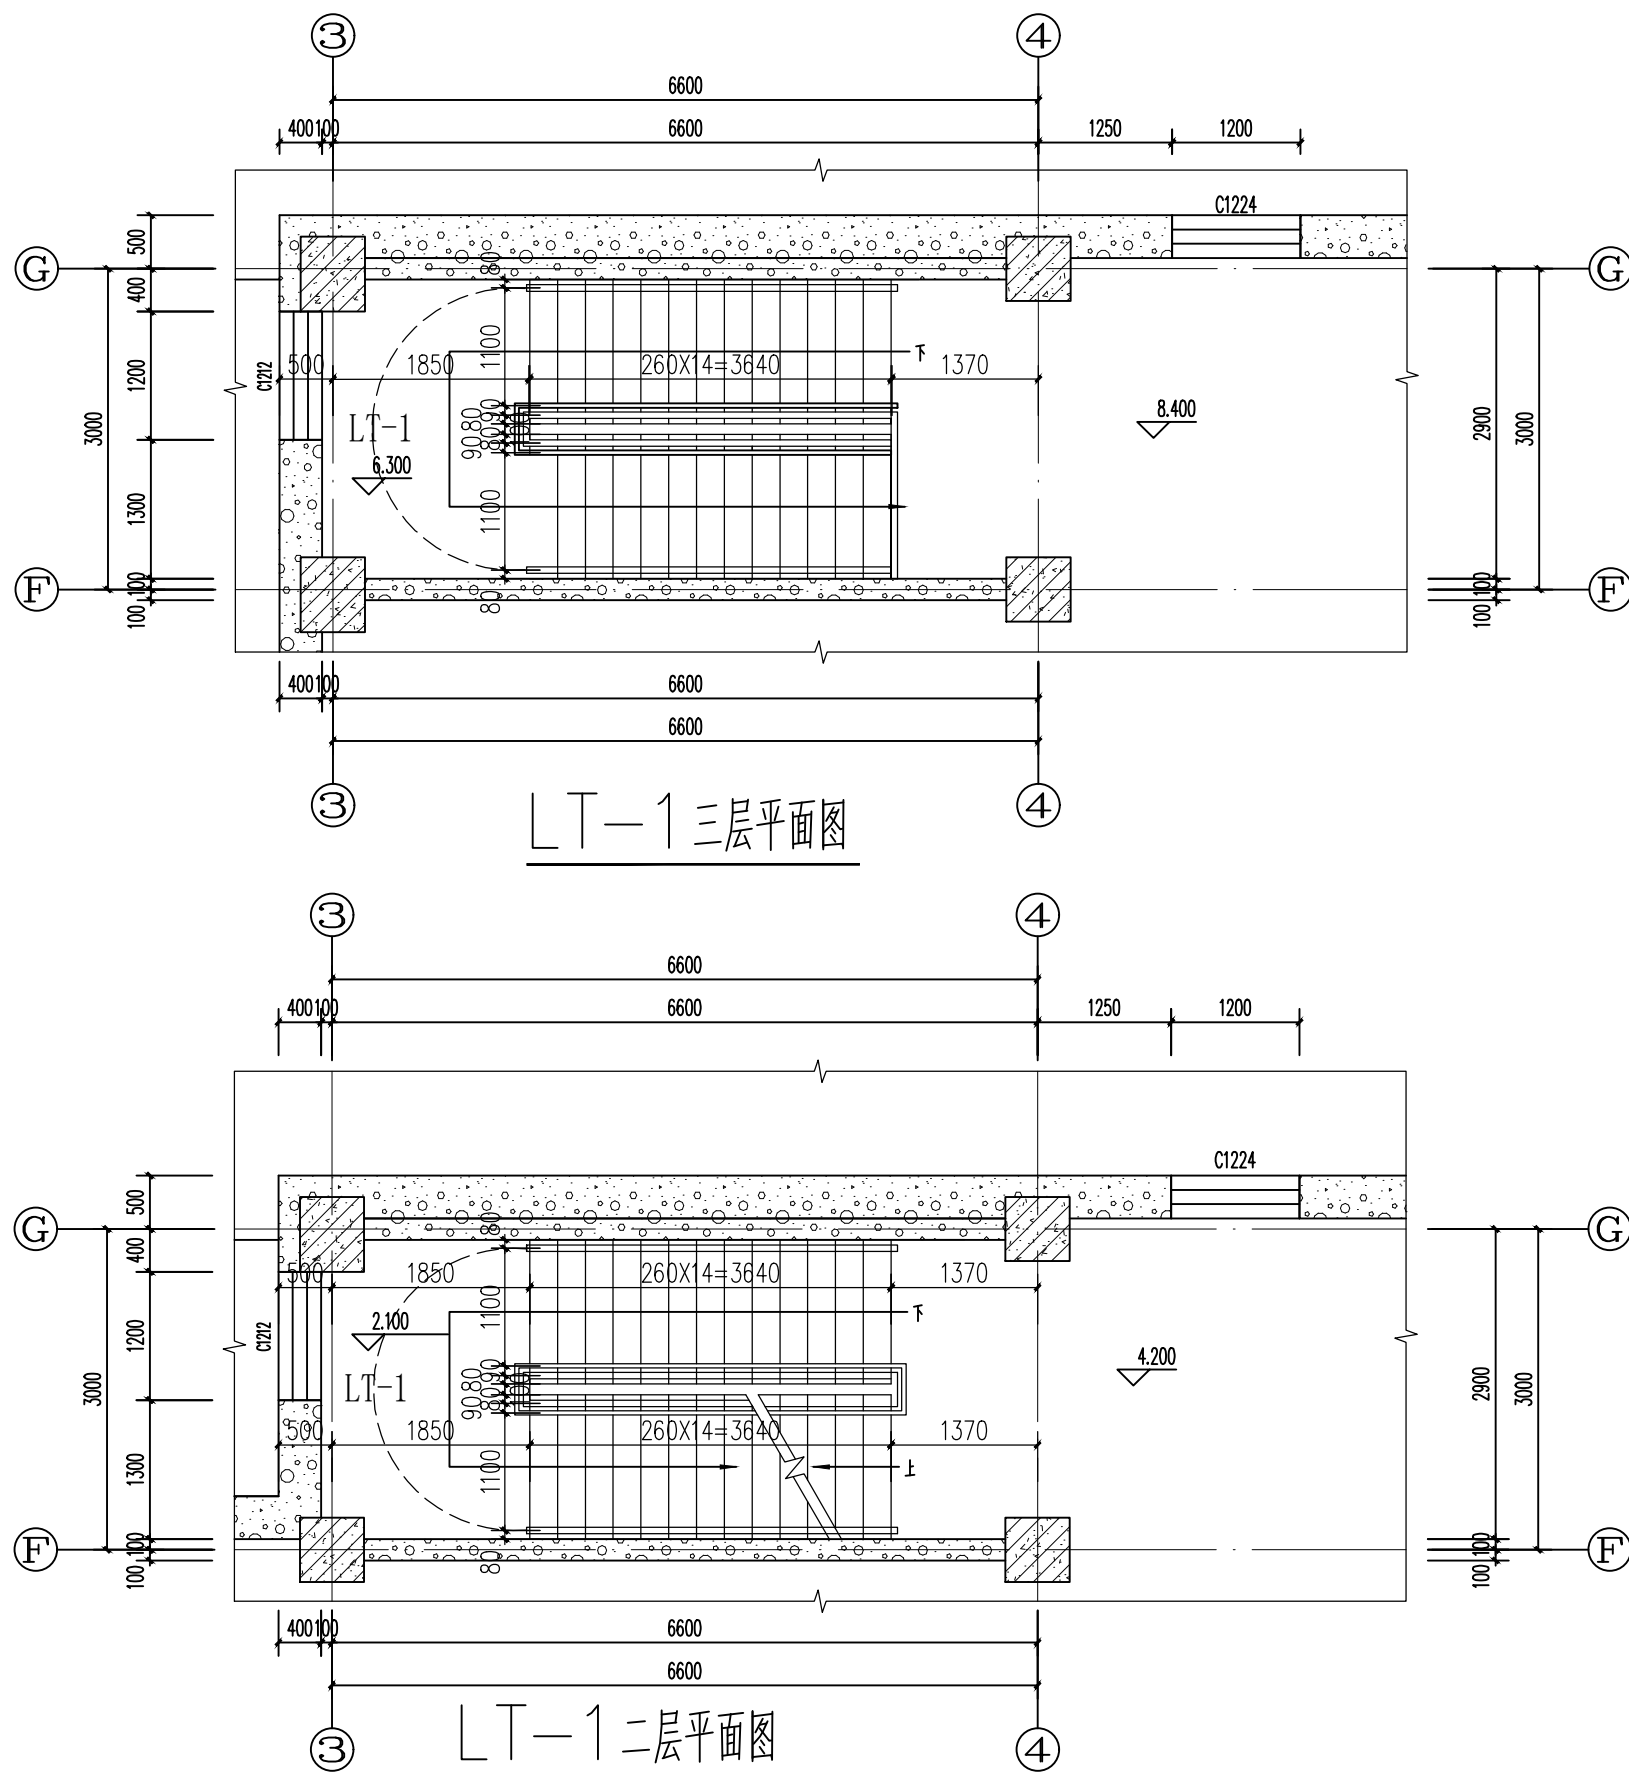
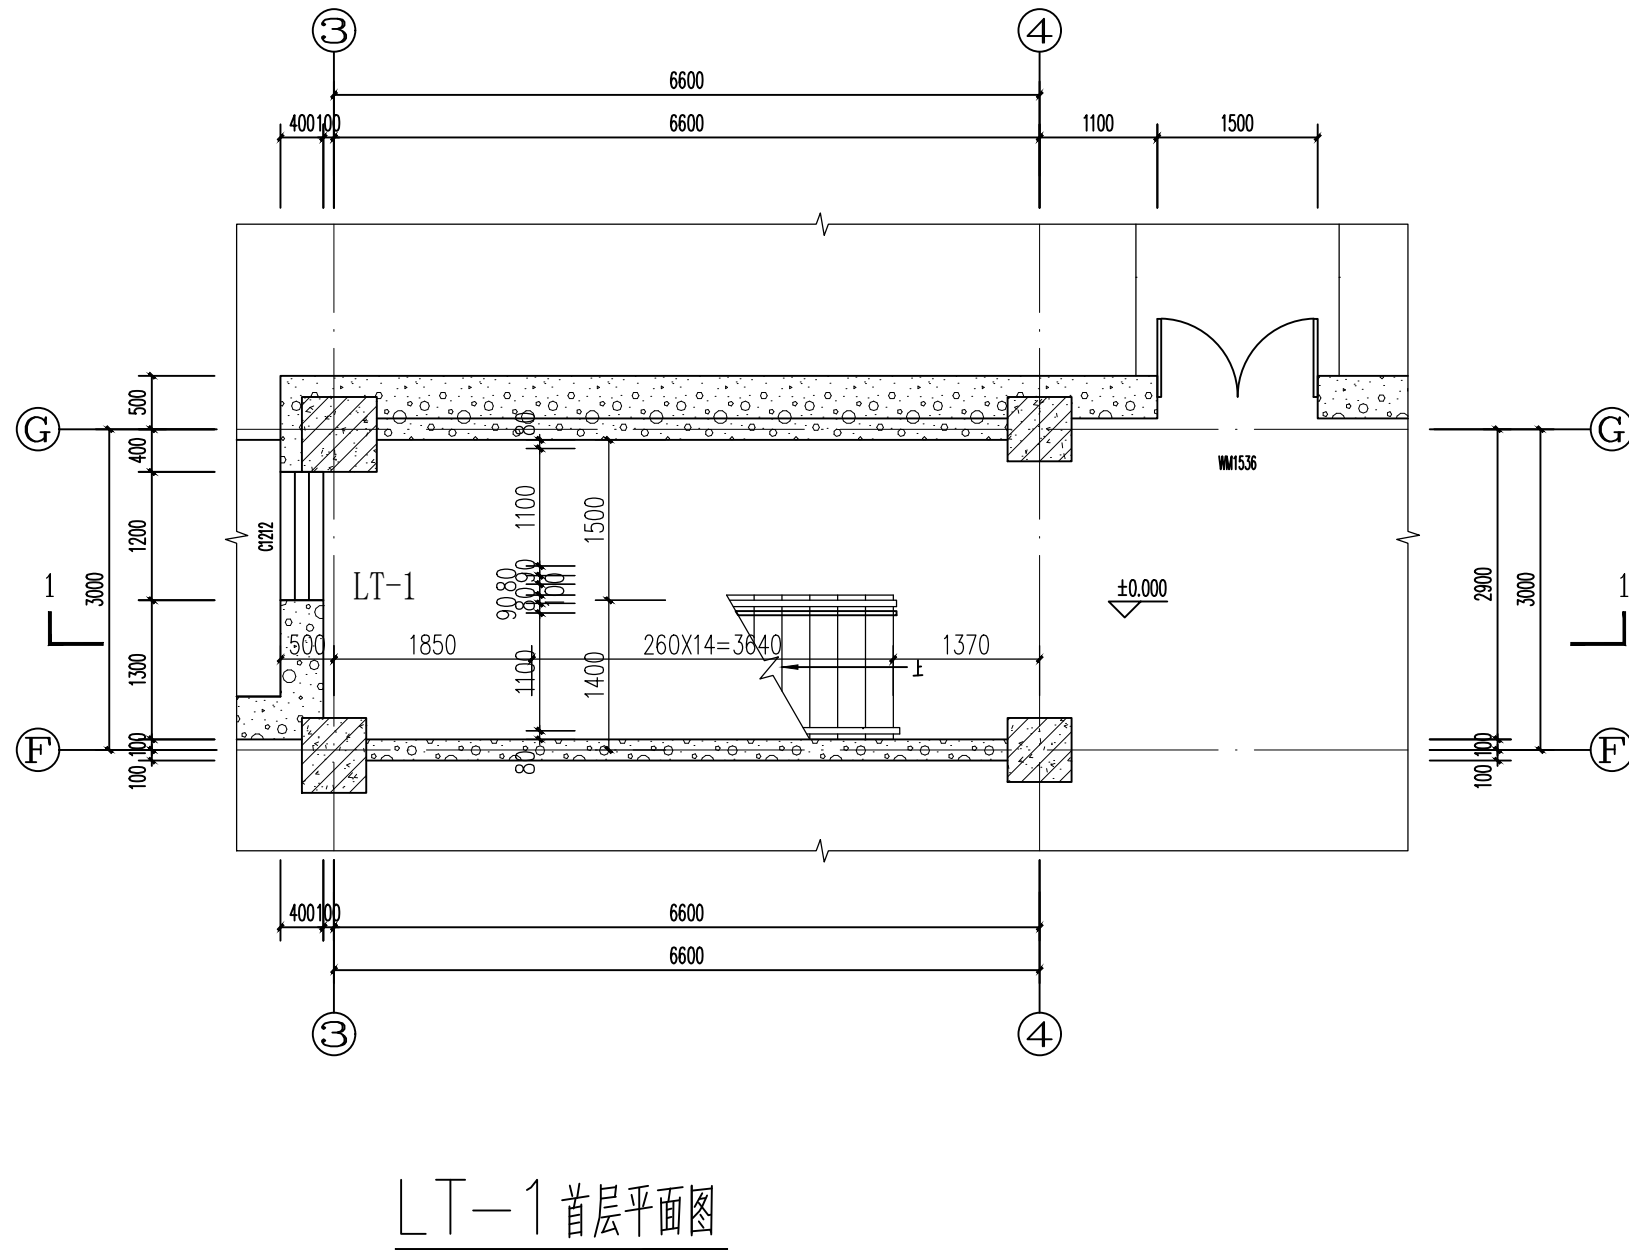


门窗表

类型	设计编号	洞口尺寸(mm)
普通门	M1023	1000X2300
	M1424	1400X2400
	WM1033	1000X3300
	WM1533	1500X3300
	WM1824	1800X2400
防火门	FM甲0721	700X2100
	FM甲0821	800X2100
	FM甲1023	1000X2300
	FM甲1221	1200X2100
	FM甲1223	1200X2300
	FM甲1521	1500X2100
	FM甲1524	1500X2400
	FM丙0721	700X2100
普通窗	C1212	1200X1200
	C1224	1200X2400
	C3926	3900X2600
	C1526	1500X2600
	C3626	3600X2600
	C4524	4500X2400
	C4826	4800X2600
	C5424	5400X2400
门联窗	MLC5730	5700X3000
	MLC2733	2700X3300
防火窗	FC甲7209	7200X900

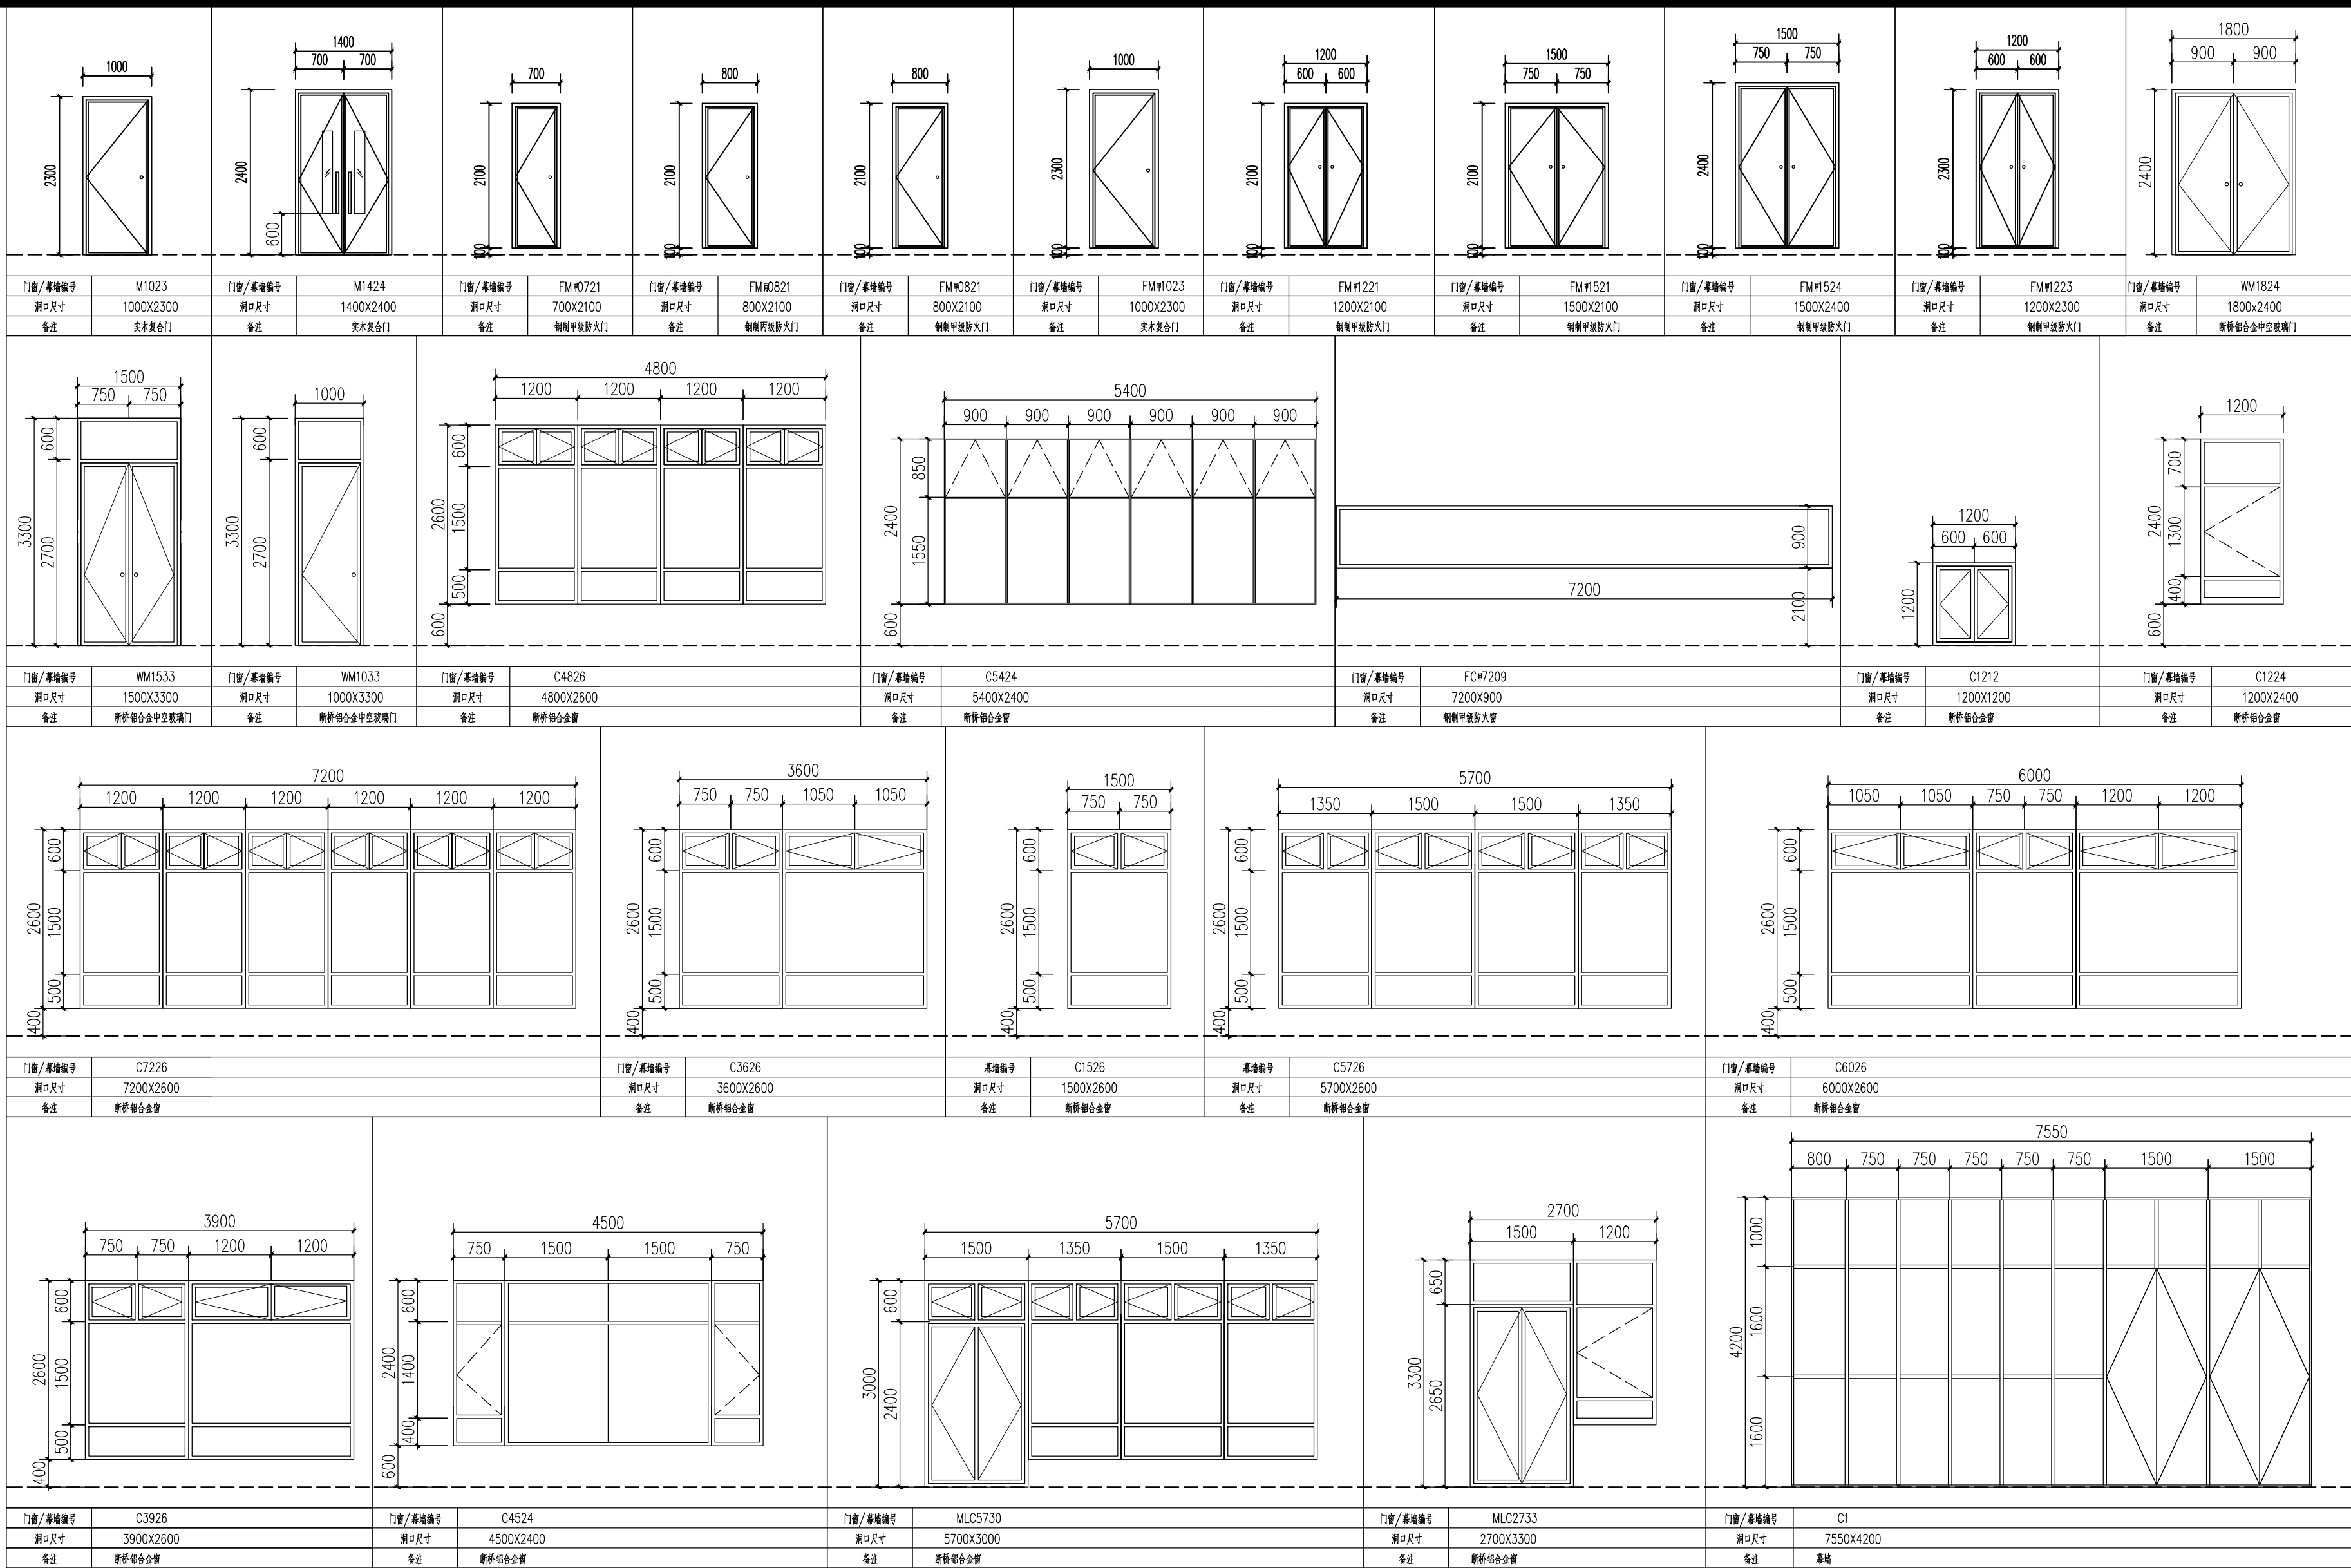

认证体系		
认证者位置 GUALIFICATION		
专业设计部门 DEPARTMENT		
设计签字 SIGNATURE		
方案设计人 SCHEMATIC DESIGNER		
设计总负责人 PROJECT ARCHITECT		
专业负责人 DISCIPLINE CHIEF		
设计人 DESIGNED BY		
验证签字 VERIFICATION		
审核人 CHECKED BY		
审定人 APPROVED BY		
会签 CONFIRMATION		
建筑专业负责人 ARCH.		
结构专业负责人 STRUCT.		
给排水专业负责人 WS&S.		
暖通专业负责人 HVAC.		
电气专业负责人 ELEC.		
项目名称 PROJECT NAME	技能操作考核样题	
项目编号 PROJECT NO.		
图名 DRAWING NAME	门窗表、门窗详图、幕墙详图、楼梯详图	
专业 DISCIPLINE	图号 DRAWING NO.	版本号 EDITION
建筑	建施09	
出图日期 DATE	年 YEAR	月 MONTH 日 DAY
归档记录 ARCHIVES		